



Note: This drawing shows the typical layout and listing of equipment in this unit. Please verify the current layout and equipment specifications with your Stewart's Mobile Concepts Representative.

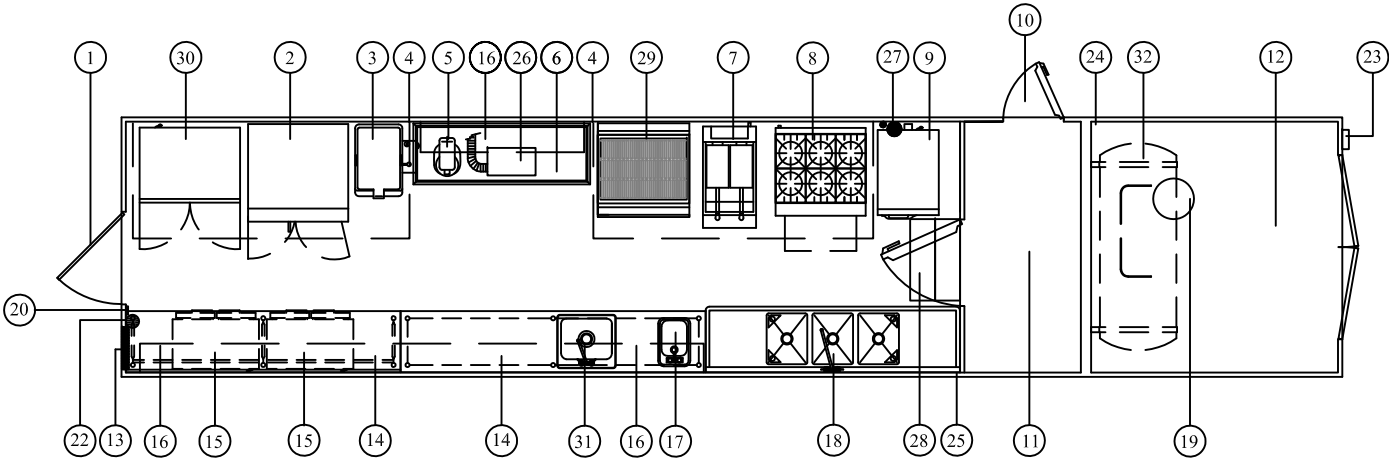

Floor Plan

Equipment List

- | | | |
|--|--|--|
| 1. Entry Door W/ Closer & Screen Curtain | 12. Utility Compartment | 22. K-Type Fire Extinguisher |
| 2. Dual Stack Convection Ovens | 13. Electrical Panel 220v / 1 Phase / 100 Amp
(Access from outside) | 23. Electrical Hook-up |
| 3. 20 Gallon Tilt Skillet | 14. S/S Counter | 24. 3/4" Fresh Water Hook-up |
| 4. S/S Exhaust Hood W/ Ansul Fire Suppression System | 15. Double Door Under Counter
Reach-in Refrigerator | 25. 3" Waste Water Hook-up |
| 5. Table Top 20 qt. Mixer | 16. S/S Over Shelf | 26. Heater/ Furnace Unit |
| 6. S/S Counter | 17. S/S Hand Sink | 27. Ansul System |
| 7. Jumbo Floor Model Fryer | 18. 3 Compartment Sink | 28. Entry Step to Walk-in |
| 8. 36" 6 Burner Range W/ Oven Below | 19. Hot Water Heater | 29. 36" Char Broiler W/ Stand |
| 9. 14 cu. ft. Reach-in Upright Freezer | 20. Ansul Pull Station | 30. Double Door Upright Freezer |
| 10. Escape Loading Door | | 31. Single Compartment Prep Sink |
| 11. Walk-in Refrigerator | | 32. 80 Gallon Propane Tank (Under Floor) |

 

Note: Items Not Shown

- * Fresh Water Holding Tank
- * Waste Water Holding Tank
- * (2) Roof Mounted A/C Units
- * Portable Entry Step for Rear Access
- * 25 kw Generator (Onboard)

Trailer Power Requirements:
220v / 1 Phase / 100 Amp

THIS PRINT IS THE PROPERTY OF STEWART'S MOBILE CONCEPTS, LTD. AND REPRESENTS A PROPRIETARY ARTICLE IN WHICH STEWART'S MOBILE CONCEPTS, LTD. RETAINS ANY AND ALL PATENT AND OTHER RIGHTS, INCLUDING EXCLUSIVE RIGHTS OF USE AND/OR MANUFACTURE, AND/OR SALE. POSSESSION OF THIS PRINT DOES NOT CONVEY ANY PERMISSION TO REPRODUCE PRINT OR MANUFACTURE ARTICLE(S) SHOWN HEREIN, SUCH PERMISSION TO BE GRANTED ONLY BY SPECIFIC AUTHORIZATION IN WRITING, SIGNED BY AN OFFICER OR OTHER AUTHORIZED AGENT OF STEWART'S MOBILE CONCEPTS, LTD. THEREOF. SPECIFICATION CANNOT BE CHANGED WITHOUT WRITTEN APPROVAL OF STEWART'S MOBILE CONCEPTS, LTD.

REV	DATE	BY	CHK	ECN #	DESCRIPTION
					STEWART'S MOBILE CONCEPTS, LTD. 845 EAST JERICHO TURNPIKE Huntington Station, New York 11746
TITLE: K-397 Overhead View					
MODEL: K-397 Hot Kitchen					
PATH: D:\Acad\StewartsMobile\K 397					PART NO.:
SCALE: NTS	PLOTS/SCALE: 1	DATE: 03/18/2009	DRAWING NO.: K-397		
DRAWN BY: RDC		LAST UPDATED: 02/18/12			